



E:\Current Proj\078388101 - Water Plant No 2 Emergency Generator\WP No.2 Emergency Generator Exhibit.dwg Apr 14, 2021-2:36pm stevenc

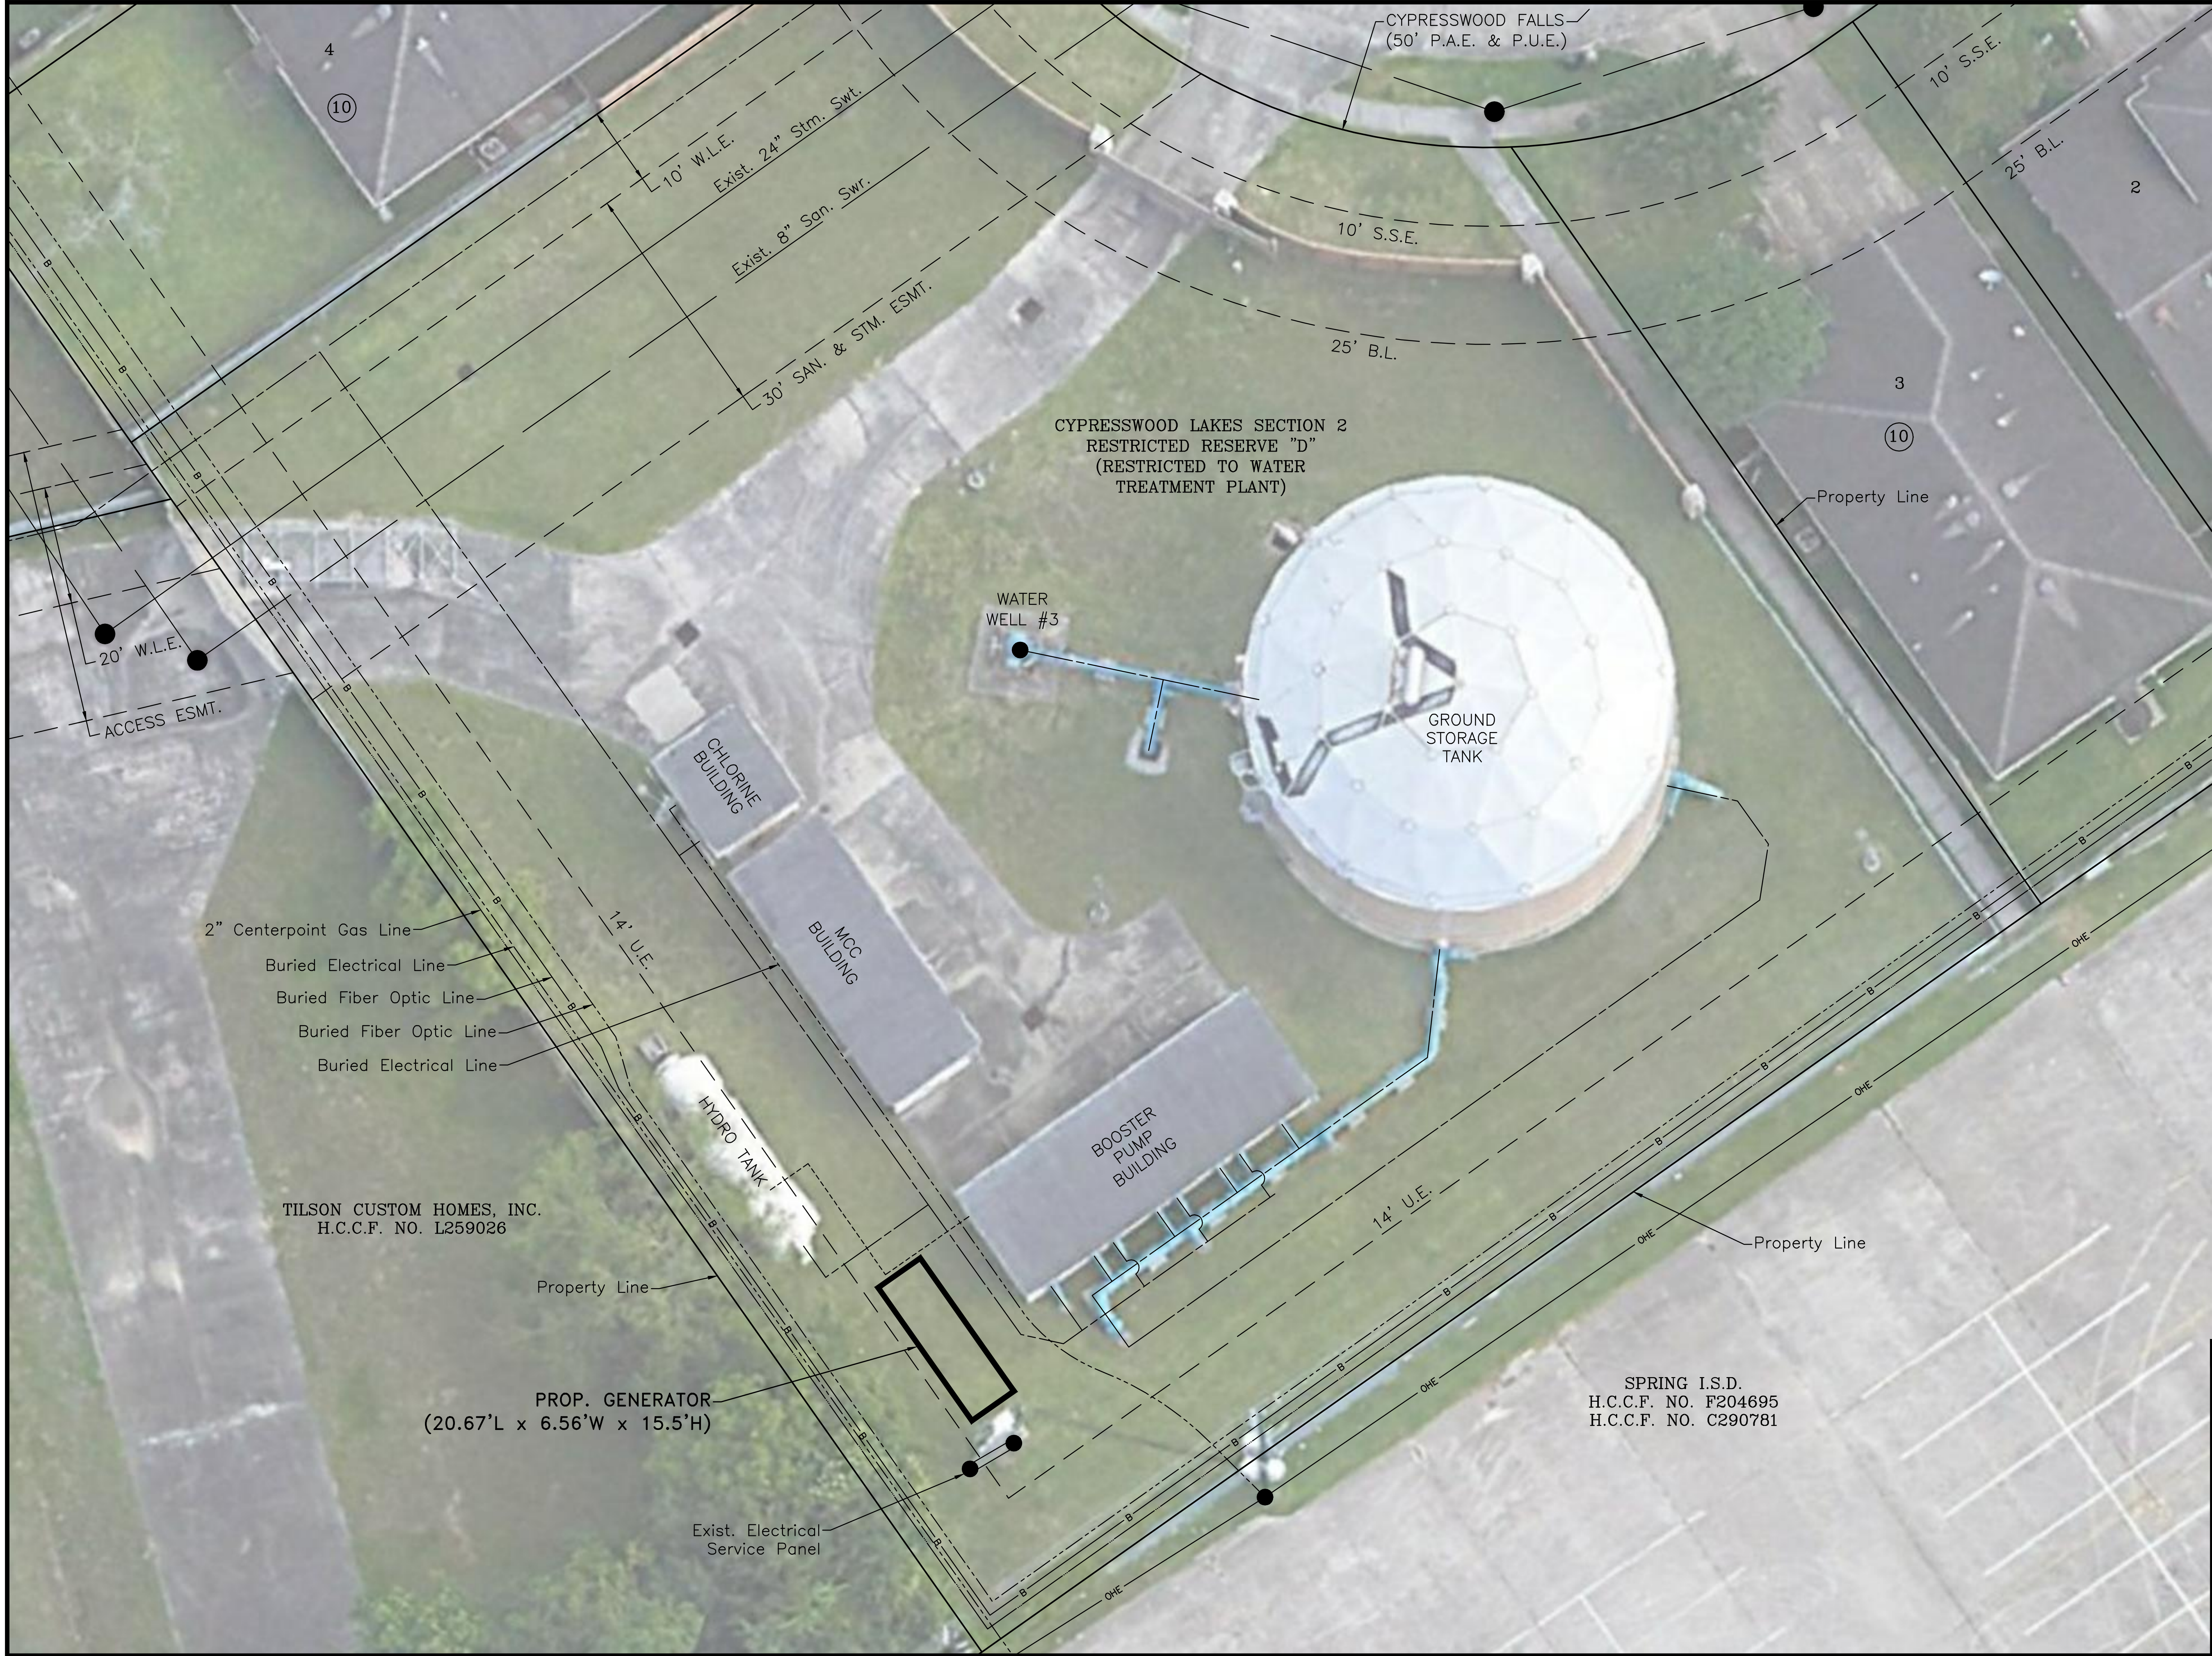

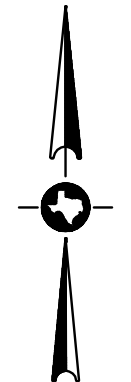

GRAPHIC SCALE X 10'

HARRIS COUNTY W.C.I.D. 110			
WATER PLANT NO. 2 EMERGENCY GENERATOR			
SITE PLAN			
 1080 W. Sam Houston Pkwy N. Ste 200 Houston, Texas 77043-5014 Ph. 713-461-3530 Fax 713-932-7505 TBPE FIRM #449			
DESIGN :	N.E.G.	JOB NO. :	078-388 101
DRAWN :	S.M.C.	DATE :	APRIL 2021
CHECKED :	J.K.D.	SCALE :	1"=10'
APPROVED :	J.K.D.	SHEET NO. :	1 OF 1